




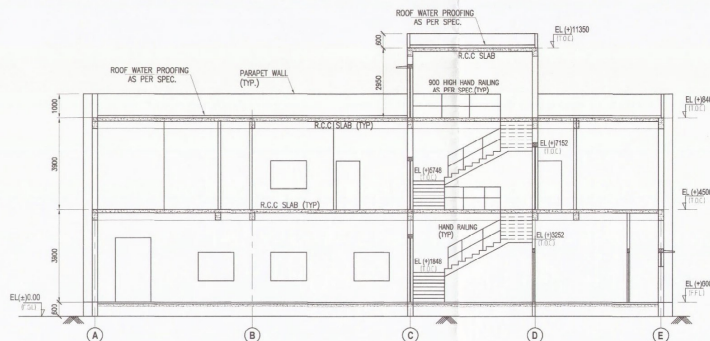


SECTION b-b

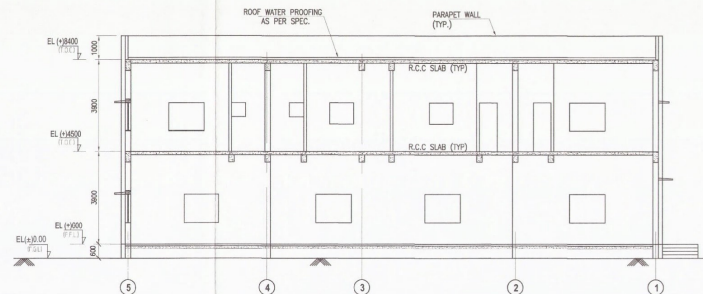


SECTION c-c

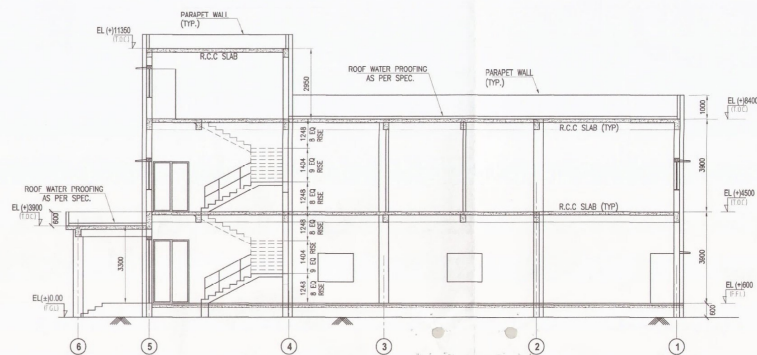


SECTION a-a

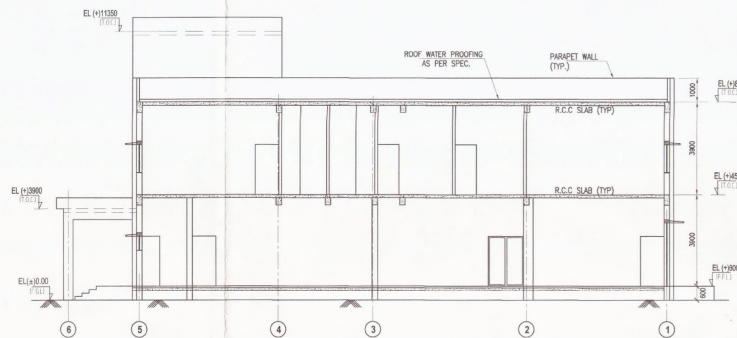


SECTION d-d

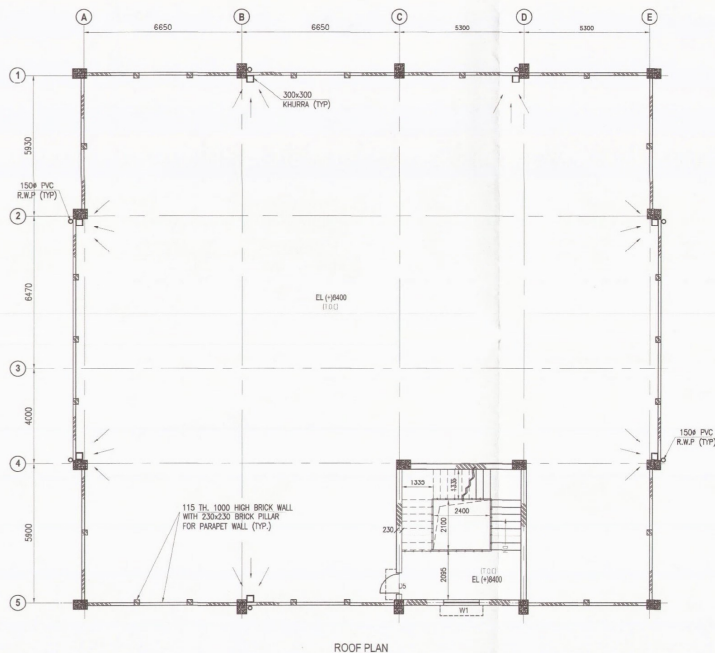


ROOF PLAN

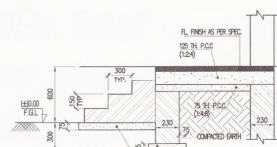


DET. OF STEPS FOR DOORS

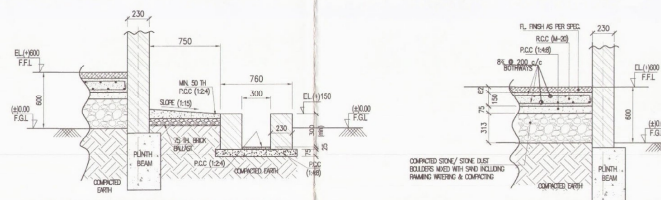


TYP. DET. OF PLINTH PROTECTION & SURFACE DRAIN

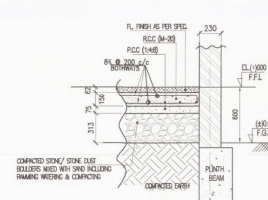


TYP. DET. OF FLOORING

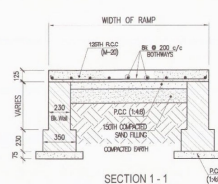


SECTION 1-1

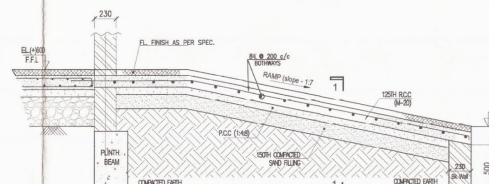


TYP. DET. OF RAMP

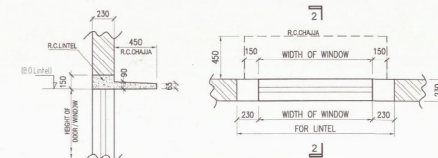


SECTION 2-2

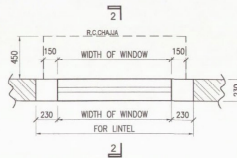

TYP. DET. OF LINTEL & CHAJJA

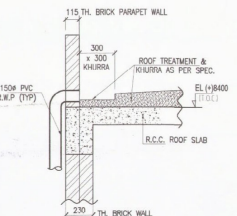

SECTION 3-3

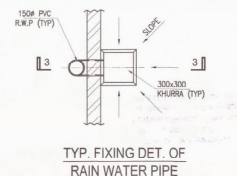

TYP. FIXING DET. OF RAIN WATER PIPE

APPROVED
Subject to confirmation and approval of the responsible authority for the execution of the work, this drawing is for reference only.

Kumar
22.12.19
Assistant Engineer (Civil)
BSPCL

Ravi
21.12
Executive Engineer (Civil)
BSPCL

Ravi
21.12
Superintending Engineer (Civil)
BSPCL

Drawing is approved subject to overall responsibility of the contractor in terms of contract agreement or, turn key for the work.
12.12.19
Chief Engineer (Civil)
BSPCL

BIHAR STATE POWER TRANSMISSION COMPANY LTD. (BSPTCL)

TITLE : CONTROL ROOM BUILDING ARCHITECTURAL DRAWING

DWG. NO. CD_220KVCRB_04 -02

SCALE : 1 : 500

SHEET 02 OF 02